


REVISIONS	DATE

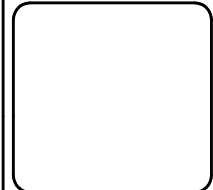

**CREATIONS  
NORTHWEST**  
West Linn, Oregon

**HARMONY ROAD  
SELF STORAGE**  
5965 SE Harmony Rd  
Milwaukie, Oregon

COMMERCIAL STORAGE BUILDINGS  
**PRELIMINARY  
LANDSCAPE  
PLAN**

CADD NAME:  
HARMONY LNDSCLP  
DATE: 7-15-15  
SCALE: AS SHOWN  
DRAWN BY: R L H  
PROJECT #HARMONY


SHEET No.  
**4.1**  
of

**LANDSCAPE LEDGEND:**

SYMBOL	SCIENTIFIC NAME	COMMON NAME	SIZE	QTY.	COMMENTS
<b>GROUNDCOVERS/ PERENNIALS</b>					
■	ACTOSTAPHYLOS UVA-URSI	KINNICKINICK	1 GAL.	3" O.C.	CONTAINER
■	CAREX STIPATA	SAWBEAK SEDGE	1 GAL.	12" O.C.	CONTAINER
■	IRIS SIBERIAN	SIBERIAN IRIS	1 GAL.	12" O.C.	CONTAINER
■	MOHONIA REPENS	CREeping MAHONIA	1 GAL.	3" O.C.	CONTAINER
■	POLYSTICHUM MUNITUM	WESTERN SWORD FERN	1 GAL.	12" O.C.	CONTAINER
■	RUBUS CALYCIROIDES	CREeping RASBERRY	4" POT	3" O.C.	CONTAINER
<b>SHRUBS</b>					
●	CORNUS ALBA 'ELAGANTISSIMA'	VARIGATED REDTRIG DOGWOOD	3 GAL.	4	CONTAINER
●	HOLODISCUS DISCOLOR	OCEANSPRAY	3 GAL.	16	CONTAINER
●	MAHONIA AQUIFOLIUM	OREGON GRAPE	5 GAL.	35	CONTAINER
●	ROSA RUGOSA	RUGOSA ROSE	3 GAL.	6	CONTAINER
●	SPIRAEA DOUGLASII	DOUGLASII WESTERN SPIRAEA	3 GAL.	3	CONTAINER
●	BERBERIS THUNDERGII	BAR BERRY	3 GAL.	30	CONTAINER
●	BOXUS SINICA	BOXWOOD	3 GAL.	21	CONTAINER
<b>TREES</b>					
●	ACER CIRCINATUM	VINE MAPLE	5-6'	5	B&B
●	CHAMAECYPARIS NOOT 'PENDULA'	WEeping ALASKAN CEDAR	6-7'	2	B&B
●	CRATAEGUS LAEV. 'CRIMSON CLOUD'	CRIMSON CLOUD HAWTHORN	1 3/4" CAL.	8	B&B
●	THUJA PLICATA 'HOGAN'	HOGAN WESTERN RED CEDAR	7-8'	2	B&B

**APPROXIMATE AREAS:**

TOTAL LOT AREA :	124,843 SQ FT
(15% = 18,726.45 SQ FT)	
BUILDING AREA:	44,116 SQ FT
LANDSCAPED AREA: BARNDOUST AND BEDS:	26,000 SQ FT
PARKING & DRIVEWAYS:	22,010 SQ FT
BALANCE OF AREA IS CREEK AND BRIDGE	

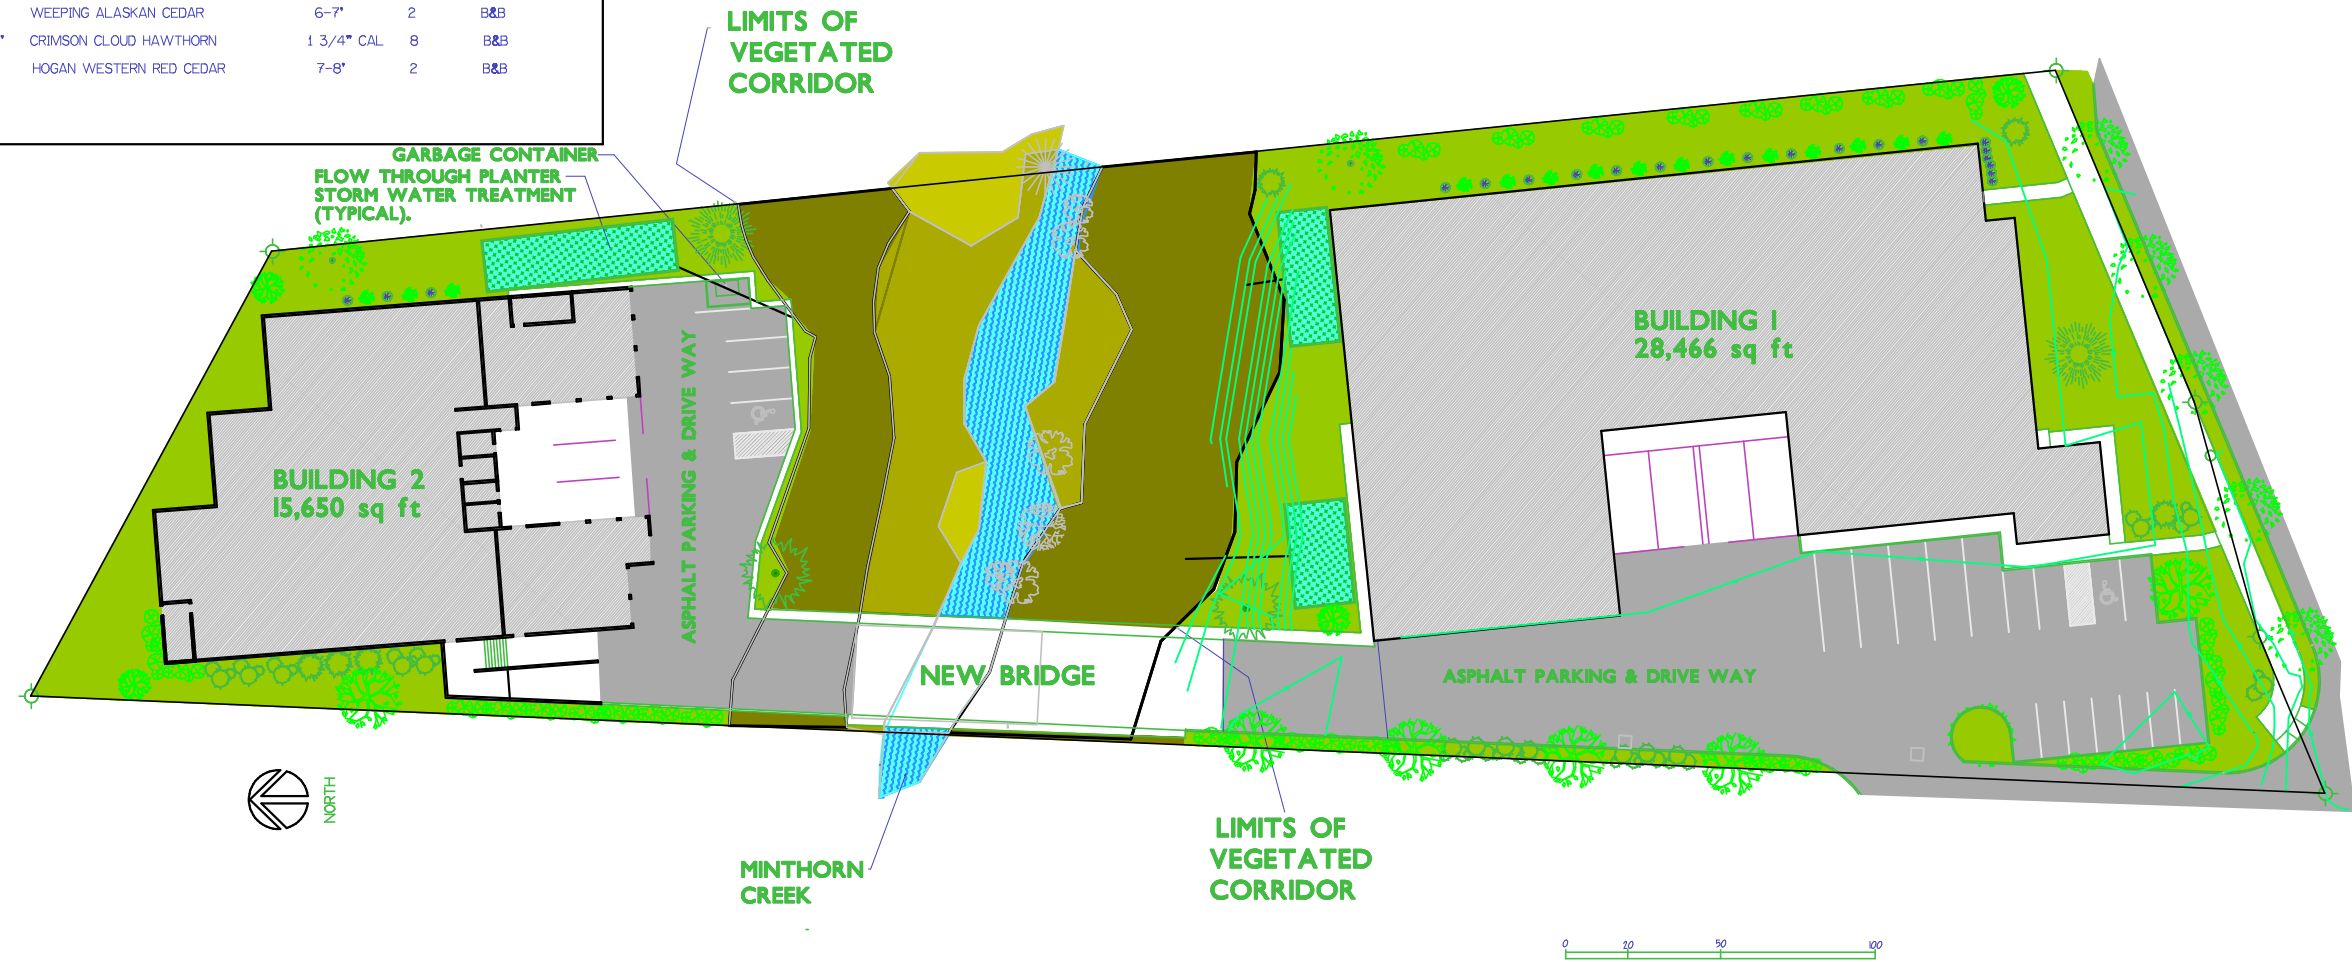

# PRELIMINARY LANDSCAPE PLAN

SCALE: 1" = 20'-0"

REVISIONS	DATE


**CREATIONS  
NORTHWEST**  
West Linn, Oregon

**HARMONY ROAD  
SELF STORAGE**  
5965 SE Harmony Rd  
Milwaukie, Oregon


COMMERCIAL STORAGE BUILDINGS  
**PRELIMINARY  
LIGHTING  
PLAN**

CADD NAME:  
HARMONY LITING  
DATE: 9-26-16  
SCALE: AS SHOWN  
DRAWN BY: R L H  
PROJECT #HARMONY

SHEET No.  
**4.2**  
of

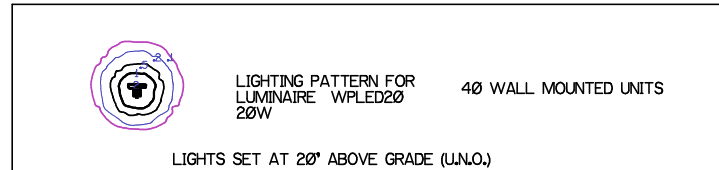

APPROXIMATE AREAS:  
TOTAL LOT AREA : 124,843 SQ FT  
(15% = 18,726.45 SQ FT)  
BUILDING AREA: 44,116 SQ FT

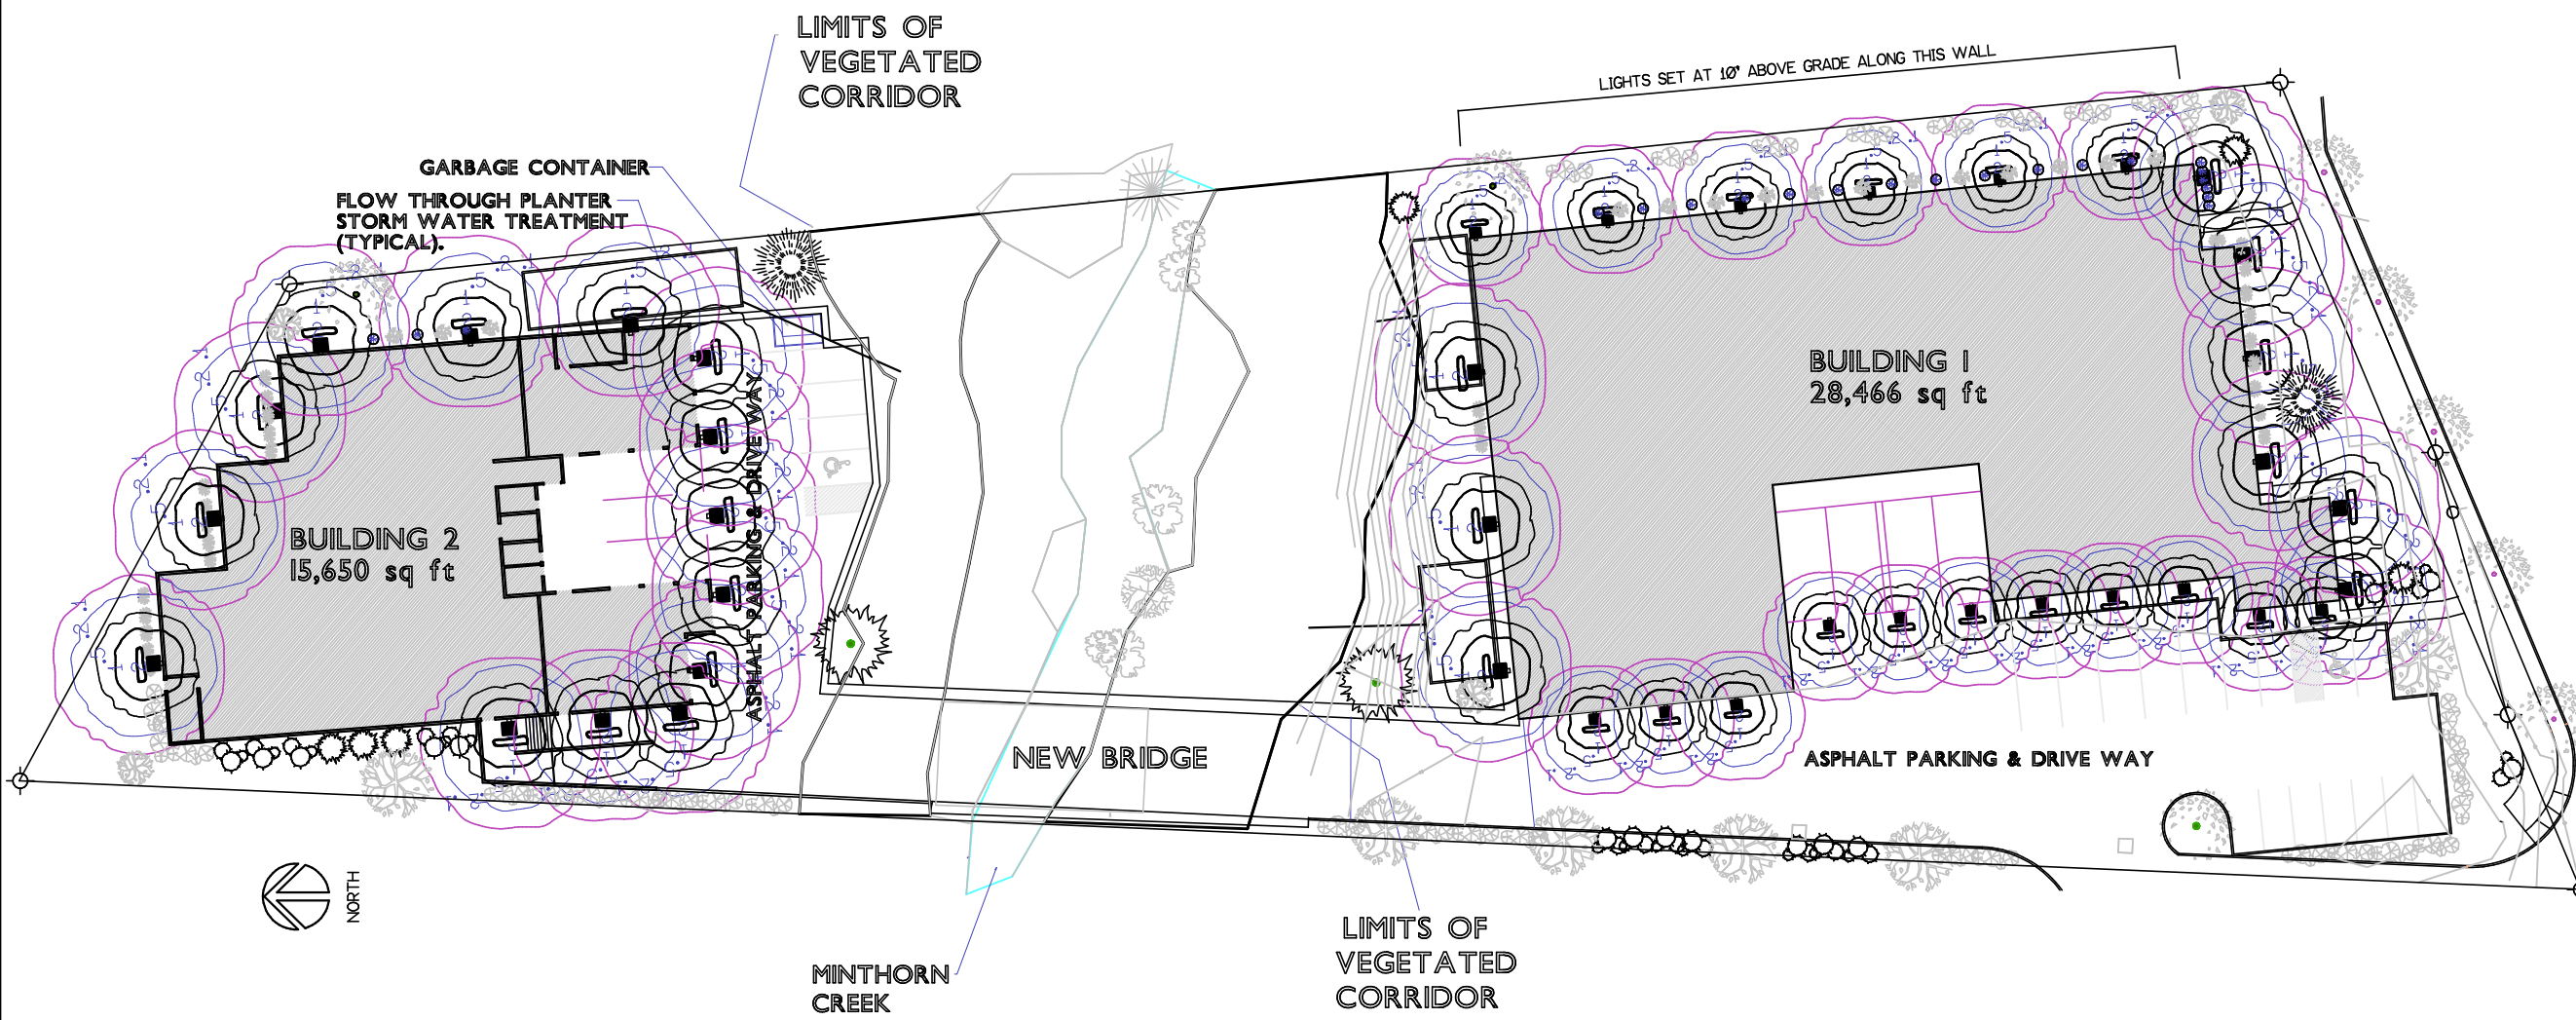

# PRELIMINARY LIGHTING PLAN

SCALE: 1" = 20'-0"